



CONTINUED ON DRAWING No.10056562-ARC-AT-110-DR-C-00011-Sheet 8

CONTINUED ON DRAWING No.10056562-ARC-AT-110-DR-C-00009-Sheet 6

- NOTES:**
- DO NOT SCALE FROM DRAWING, USE FIGURED DIMENSIONS ONLY.
 - ALL UNITS IN METRES UNLESS STATED OTHERWISE.
 - REFER TO DRAWING 10056562-ARC-AT-110-DR-C-00003-00013 FOR GENERAL ARRANGEMENT DRAWINGS

- KEY**
- PROPOSED SHARED FOOTWAY/CYCLEWAY
 - PROPOSED EARTHWORKS
 - PROPOSED VERGE
 - PROPOSED FENCE
 - EXISTING 10m LIGHTING COLUMN TO BE RETAINED
 - EXISTING 10m LIGHTING COLUMN TO BE REMOVED DUE TO CONFLICTING WITH THE PROPOSED ALIGNMENT
 - PROPOSED 10m LIGHTING COLUMN TO REPLACE EXISTING LIGHTING COLUMN.
 - PROPOSED 5m LIGHTING COLUMN.
 - PROPOSED 1.1m BOLLARDS 0.40km 2700k 240° BEAM SPREAD.
 - PROPOSED 1.1m BOLLARDS 0.19km 2700k 240° BEAM SPREAD.
 - PROPOSED 1.1m BOLLARDS 0.24km 2700k 240° BEAM SPREAD.
 - LIGHTING CONTOUR 0.2 LUX
 - LIGHTING CONTOUR 0.5 LUX
 - LIGHTING CONTOUR 1.0 LUX
 - LIGHTING CONTOUR 5.0 LUX
 - LIGHTING CONTOUR 10.0 LUX
 - LIGHTING CONTOUR 15.0 LUX
 - LIGHTING CONTOUR 20.0 LUX

P01	18/10/24	FIRST ISSUE	DD	MP	SD	MG
Rev	Date	Description	Prod.	Chk.	Rev.	App.

VALE of GLAMORGAN
BRŷ MORGANWŶG

Project:
Sully to Cosmeston ATR

Site: Sully to Cosmeston Cardiff
 Client: Vale of Glamorgan Council
 Cynfor Bro Morgannwg
 Civic Offices, Holtton Road
 Barry - CF63 4RU
 www.valeofglamorgan.gov.uk

ARCADIS

Registered office: 80 Fenchurch Street, London EC3M 4BY
 Coordinating office: Arcadis Suite 4d, 4th Floor, Hodge House, 144-166 St Mary St, Cardiff CF10 1DY
 Tel: 44 (0)29 2092 6700
 www.arcadis.com © Copyright reserved


PROPOSED STREET LIGHTING LAYOUT SHEET 7

Designed: C.Chambers	Signed: Digitally Signed	Date: 03/10/24
Produced: D.Doyle	Signed: Digitally Signed	Date: 10/10/24
Checked: M.Pearson	Signed: Digitally Signed	Date: 18/10/24
Reviewed: S.Davies	Signed: Digitally Signed	Date: 18/10/24
Approved: M.Griffiths	Signed: Digitally Signed	Date: 18/10/24

Original Size: A1	Grid: OS	Datum: ODN
Suitability Code: S3	Scale: 1:500	Project Number: 10056562

Suitable for Review and Comment

Drawing Number: 10056562 - ARC - AT - 130 - DR - C - 00007	Revision: P01
------------------------------------------------------------	---------------

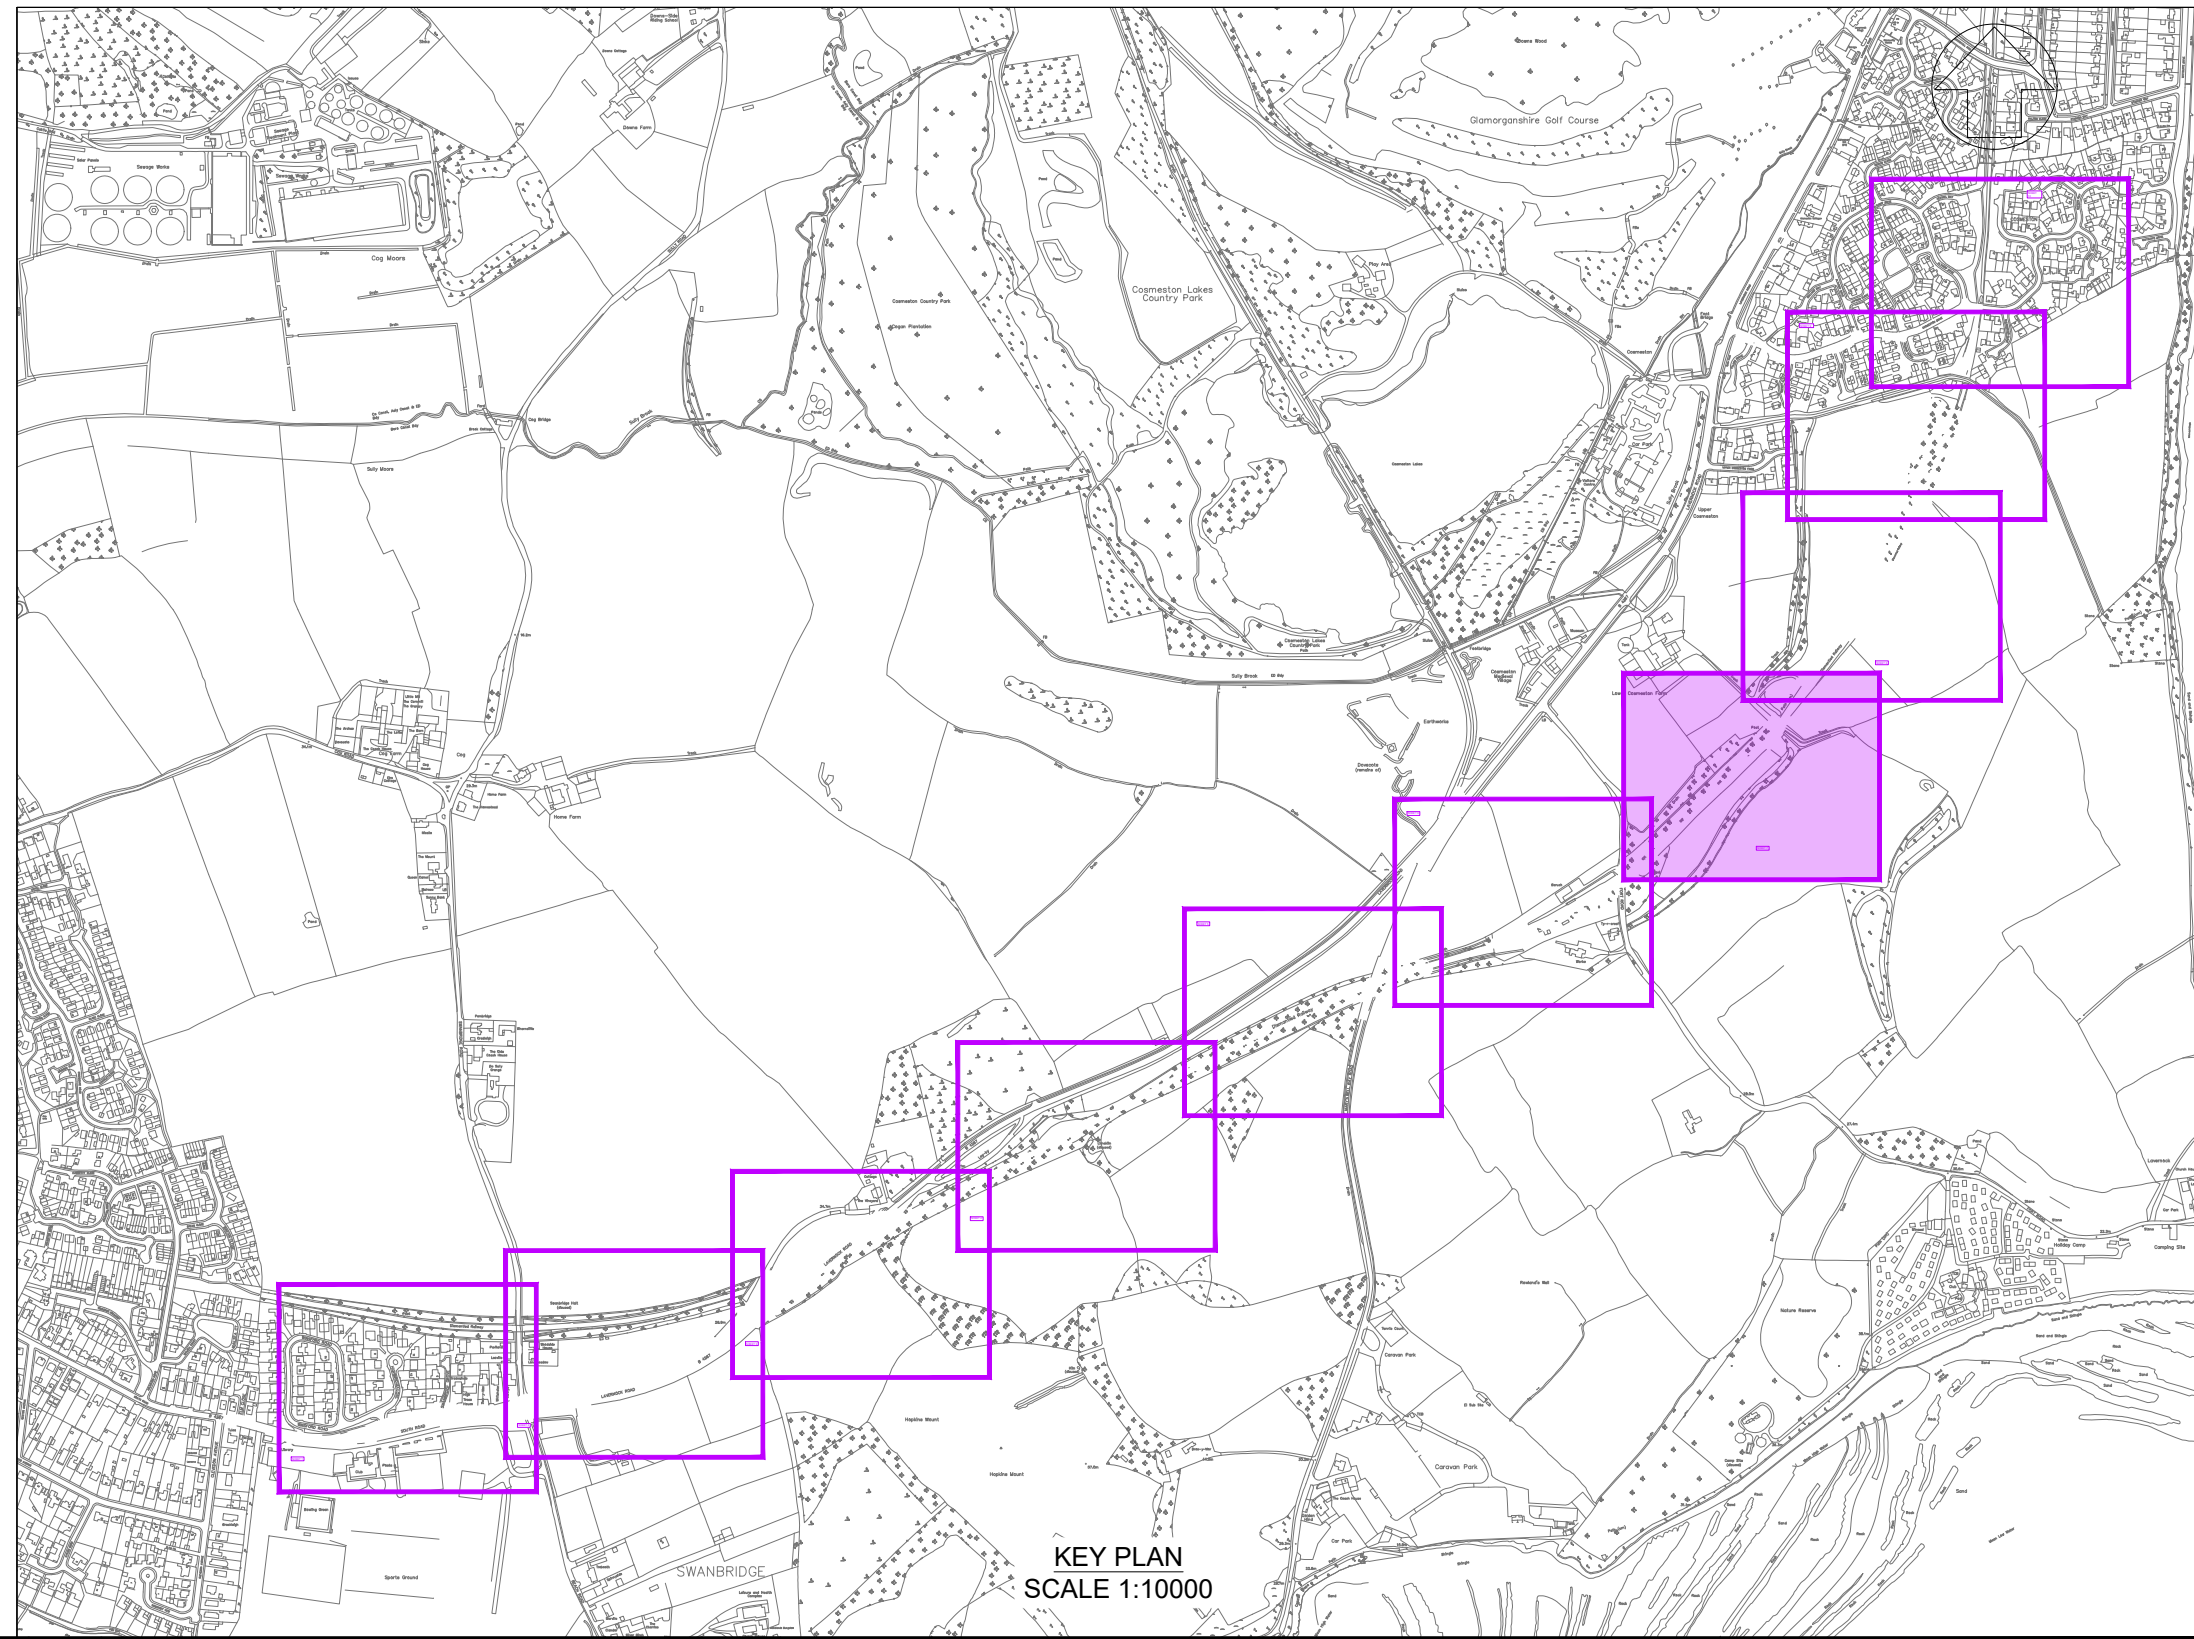

SCALE 1:500 (A1)
 SCALE 1:1000 (A3)
 METRES

Print Date: 2024-10-18 17:01:31

C:\bms\arcadis-uk-09\dms4670\110056562-ARC-AT-130-DR-C-00007.dwg